




## CROSS/SECTIONS

DRAWING	DESCRIPTION
INDEX MAP	CROSS SECTION INDEX MAP
FIGURE 1 LEMF	TYPICAL CROSS SECTION SCOVILL ROCK S/S TO CHESTNUT JCT.
FIGURE 2 LEMF	TYPICAL CROSS SECTION OXBOW JCT TO EAST OF ROYAL OAK AND MIDDLEFIELD TO BESECK S/S
FIGURE 3 LEMFB	TYPICAL CROSS SECTION BLACK POND JCT TO MERIDEN P.B.A.
FIGURE 3	TYPICAL CROSS SECTION MERIDEN P.B.A. TO EAST MERIDEN S/S
FIGURE 4	TYPICAL CROSS SECTION EAST MERIDEN S/S TO BESECK S/S

## PLAN DRAWINGS

DRAWING	DESCRIPTION
01225-15001 SHEET 1 OF 7	BESECK S/S - OXBOW JCT 345/115kV LINE DEVELOPMENT & MANAGEMENT PLAN
01225-15001 SHEET 2 OF 7	BESECK S/S - OXBOW JCT 345/115kV LINE DEVELOPMENT & MANAGEMENT PLAN
01225-15001 SHEET 3 OF 7	BESECK S/S - OXBOW JCT 345/115kV LINE DEVELOPMENT & MANAGEMENT PLAN
01225-15001 SHEET 4 OF 7	BESECK S/S - OXBOW JCT 345/115kV LINE DEVELOPMENT & MANAGEMENT PLAN
01225-15001 SHEET 5 OF 7	BESECK S/S - OXBOW JCT 345/115kV LINE DEVELOPMENT & MANAGEMENT PLAN
01225-15001 SHEET 6 OF 7	BESECK S/S - OXBOW JCT 345/115kV LINE DEVELOPMENT & MANAGEMENT PLAN
01225-15001 SHEET 7 OF 7	BESECK S/S - OXBOW JCT 345/115kV LINE DEVELOPMENT & MANAGEMENT PLAN
01225-15002	BESECK S/S - OXBOW JCT 345/115kV LINE EROSION CONTROL DETAILS
01225-60001	BESECK S/S - OXBOW JCT 345/115kV LINE TYPICAL FOUNDATION DETAILS
01227-15001 SHEET 1 OF 3	BESECK S/S - BLACK POND JCT 345/115kV LINE DEVELOPMENT & MANAGEMENT PLAN
01227-15001 SHEET 2 OF 3	BESECK S/S - BLACK POND JCT 345/115kV LINE DEVELOPMENT & MANAGEMENT PLAN
01227-15001 SHEET 3 OF 3	BESECK S/S - BLACK POND JCT 345/115kV LINE DEVELOPMENT & MANAGEMENT PLAN
01227-15002	BESECK S/S - BLACK POND JCT 345/115kV LINE EROSION CONTROL DETAILS
01227-60001	BESECK S/S - BLACK POND JCT 345/115kV LINE TYPICAL FOUNDATION DETAILS
01228-15001 SHEET 1 OF 3	CHESTNUT JCT - SCOVILL ROCK S/S 345kV LINE DEVELOPMENT & MANAGEMENT PLAN
01228-15001 SHEET 2 OF 3	CHESTNUT JCT - SCOVILL ROCK S/S 345kV LINE DEVELOPMENT & MANAGEMENT PLAN
01228-15001 SHEET 3 OF 3	CHESTNUT JCT - SCOVILL ROCK S/S 345kV LINE DEVELOPMENT & MANAGEMENT PLAN
01228-15002	CHESTNUT JCT - SCOVILL ROCK S/S 345kV LINE EROSION CONTROL DETAILS
01228-60001	CHESTNUT JCT - SCOVILL ROCK S/S 345kV LINE TYPICAL FOUNDATION DETAILS

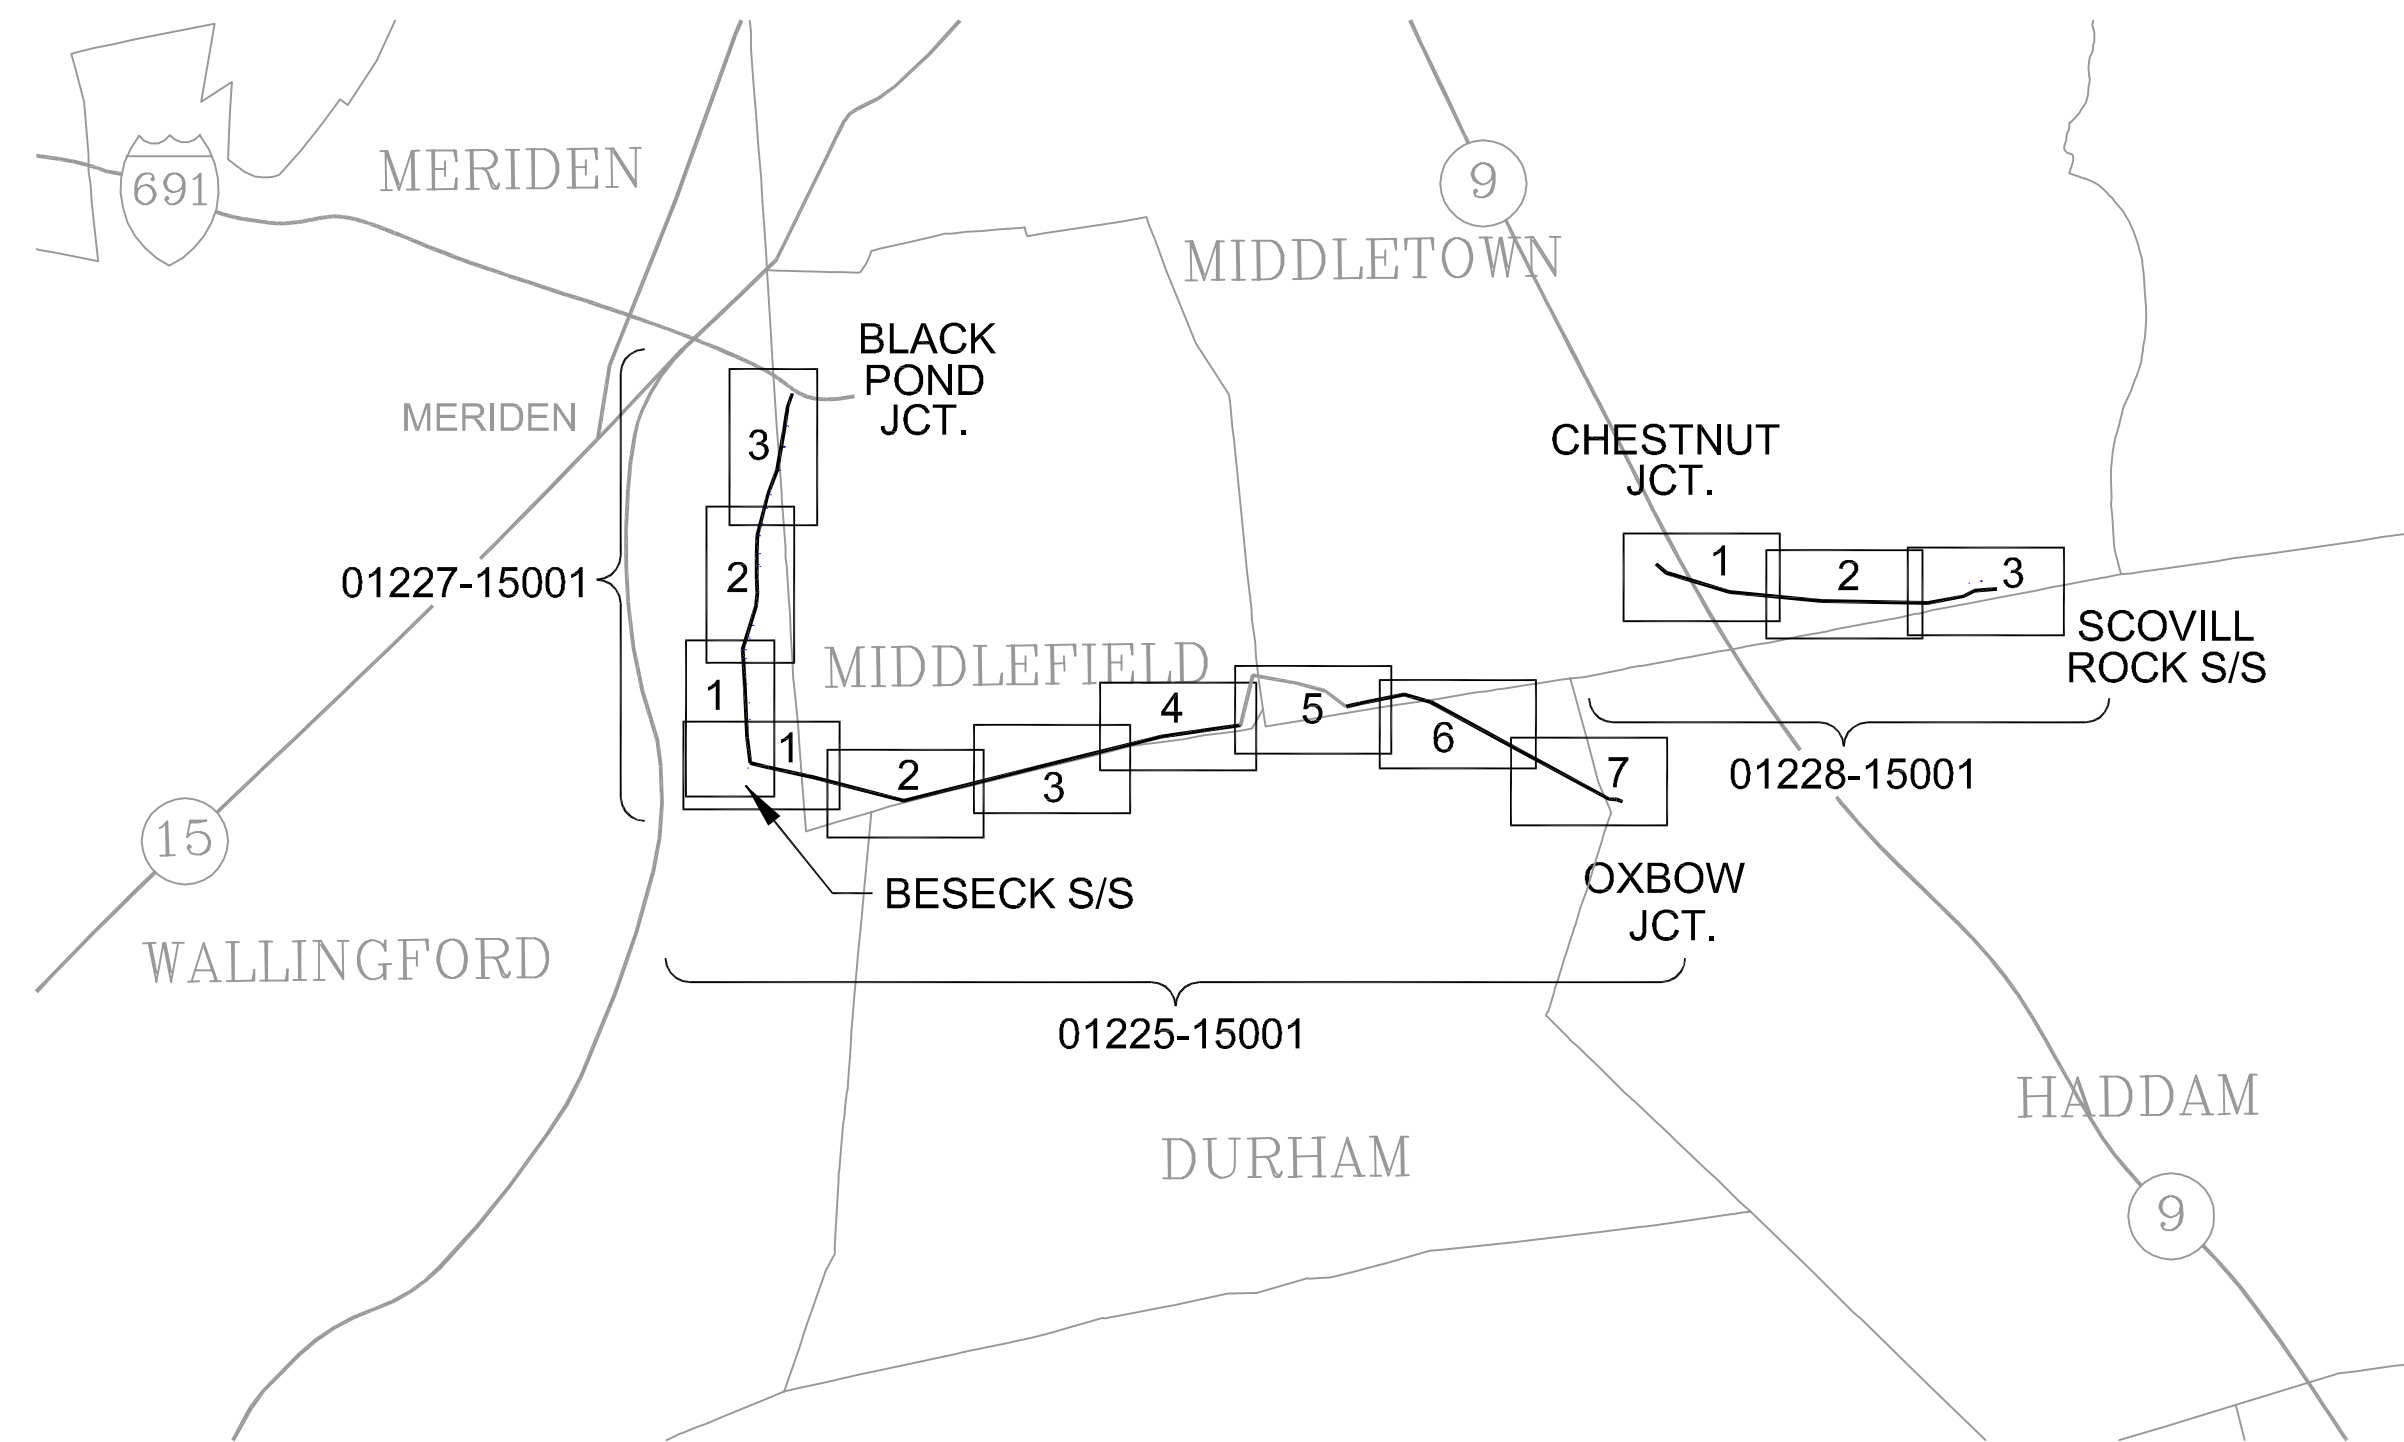

INDEX OF PLAN DRAWINGS



38565

date AUGUST 4, 2005  
 designed M. COLLINS  
 detailed J. BOYER  
 checked J. HOGAN

CAD GENERATED DWG

MAKE NO MANUAL CHANGES

NORTHEAST UTILITIES SERVICE CO.									
FOR THE CONNECTICUT LIGHT & POWER CO.									
TITLE DEVELOPMENT & MANAGEMENT PLAN SEGMENT 1A INDEX									
BY	BMCD	CHKD	-	APP	-	APP	-		
DATE	SEPT 2005	DATE	-	DATE	-	DATE	-		
SCALE	NONE			D	DWG. NO.		INDEX		
NO.	DATE	REVISIONS	BY	CHK	APP	APP			